



1 WEST ELEVATION
SK 4 SCALE: 1:175

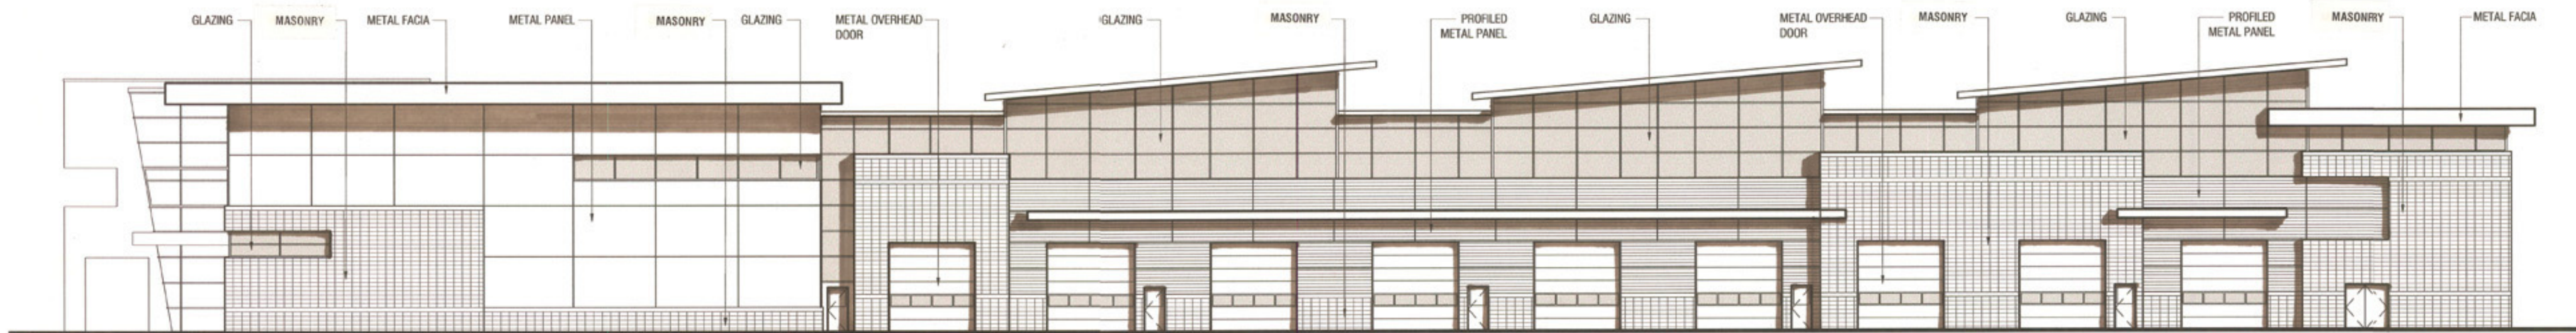

2 SOUTH ELEVATION
SK 4 SCALE: 1:175

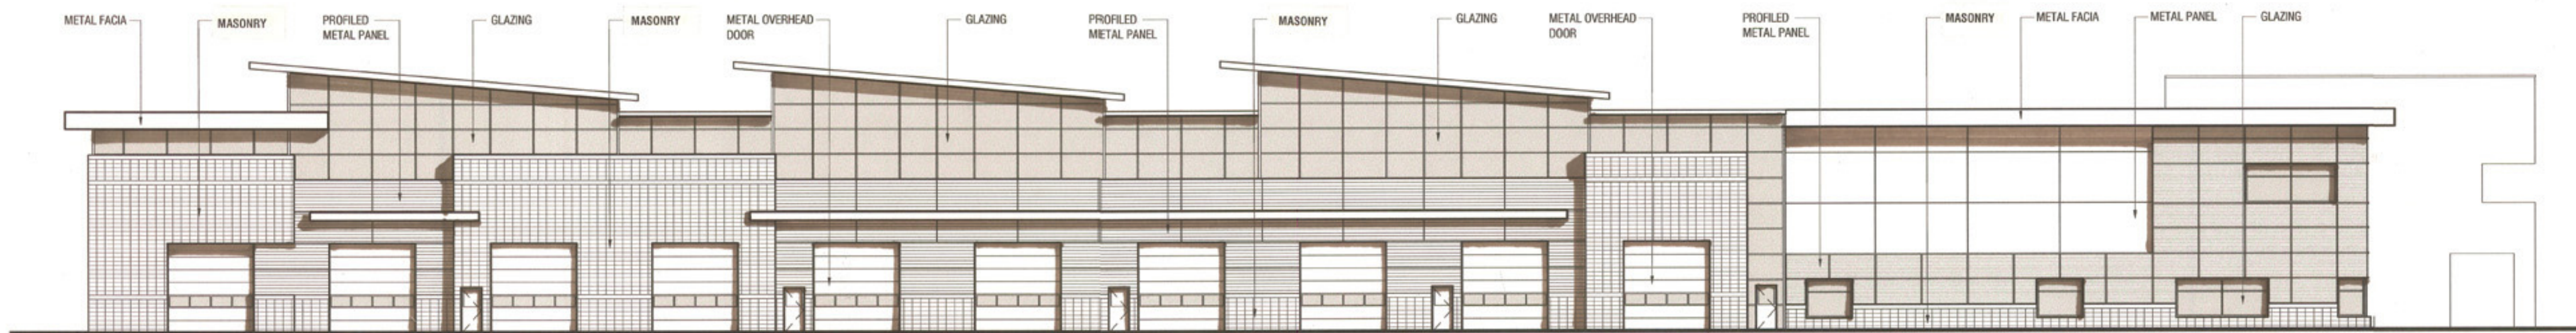

3 NORTH ELEVATION
SK 4 SCALE: 1:175

CONCEPT DRAWING ONLY

THIS DRAWING IS CONCEPTUAL ONLY AND WILL CHANGE.
BUILDING SIZE, MASSING, IMAGERY AND OTHER ELEMENTS WILL
CHANGE AS THE DESIGN EVOLVES AND BECOMES FINALIZED.

P:\PROJECTS\2008 PROJECTS\200807 CITY OF CALGARY - APPARATUS REPAIR AND TESTING FACILITY FOR FIRE SERVICES.DSCAD\01 DESIGN\01 4 SCHEMATIC DESIGN\LINE-19-2007\015-A1-SK4-ELEVATIONS.DWG 13-JUN-2007 11:38:47 AM

CONCEPTUAL ELEVATIONS

FIRE HEADQUARTERS / APPARATUS TRAINING & MAINTENANCE FACILITY
CITY OF CALGARY



This drawing and design are Copyright © 2005, S2 Architecture. These drawings may not be reproduced without the permission of the Architect. The images depicted represent a preliminary design and are subject to change. This drawing is not to be used for construction.